


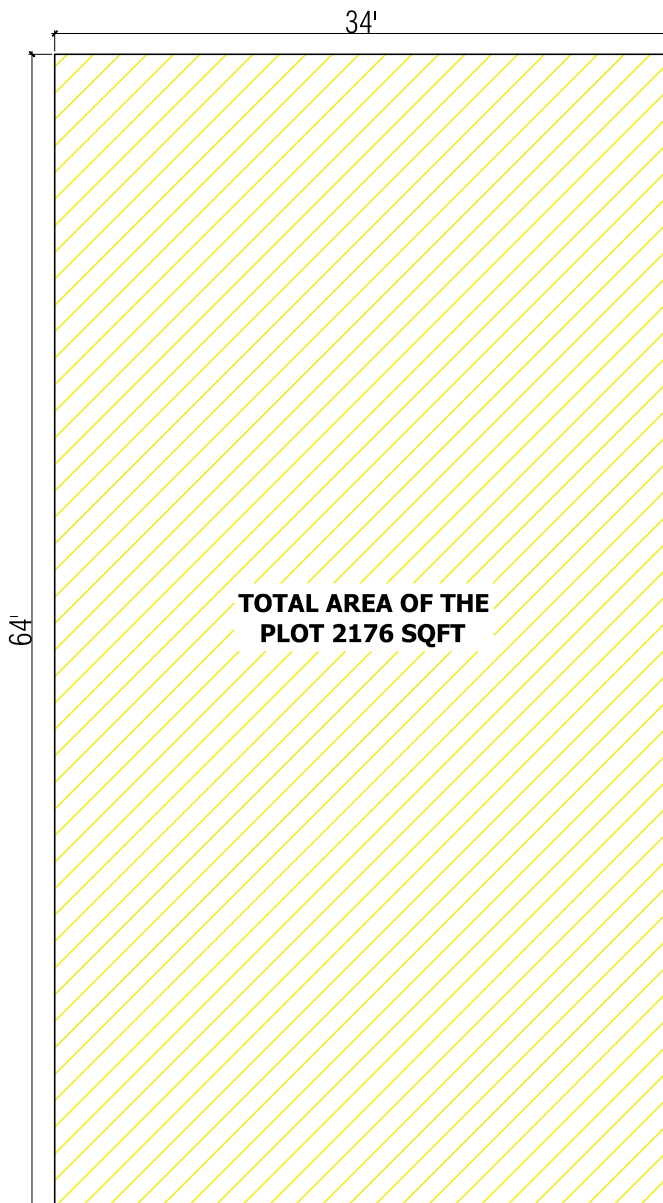



AREA STATEMENT

BUILT UP AREA SUMMARY		
BUILT UP AREA		
AREA OF GROUND FLOOR	2116.00	SQFT
AREA OF FIRST FLOOR	2040.00	SQFT
AREA OF SECOND FLOOR	250.25	SQFT
TOTAL BUILT UP AREA	4406.250	SQFT.
AREA OF PLOT	2176.00	SQFT.

ROAD 16' WIDE

SITE PLAN & COVERED AREA DETAILS




**IBN-E-ASGHAR
& Associates**
Architect, Engineer, Planners,
Interior designers & Consultants
Phone: 03087279678

Client: MR. SHOUKAT HUSSAIN
Project: BUR-E-WALA

Title: AREA STATMENT
Sub-title: SITE PLAN

Date: 05-09-2025
Scale: N.T.S

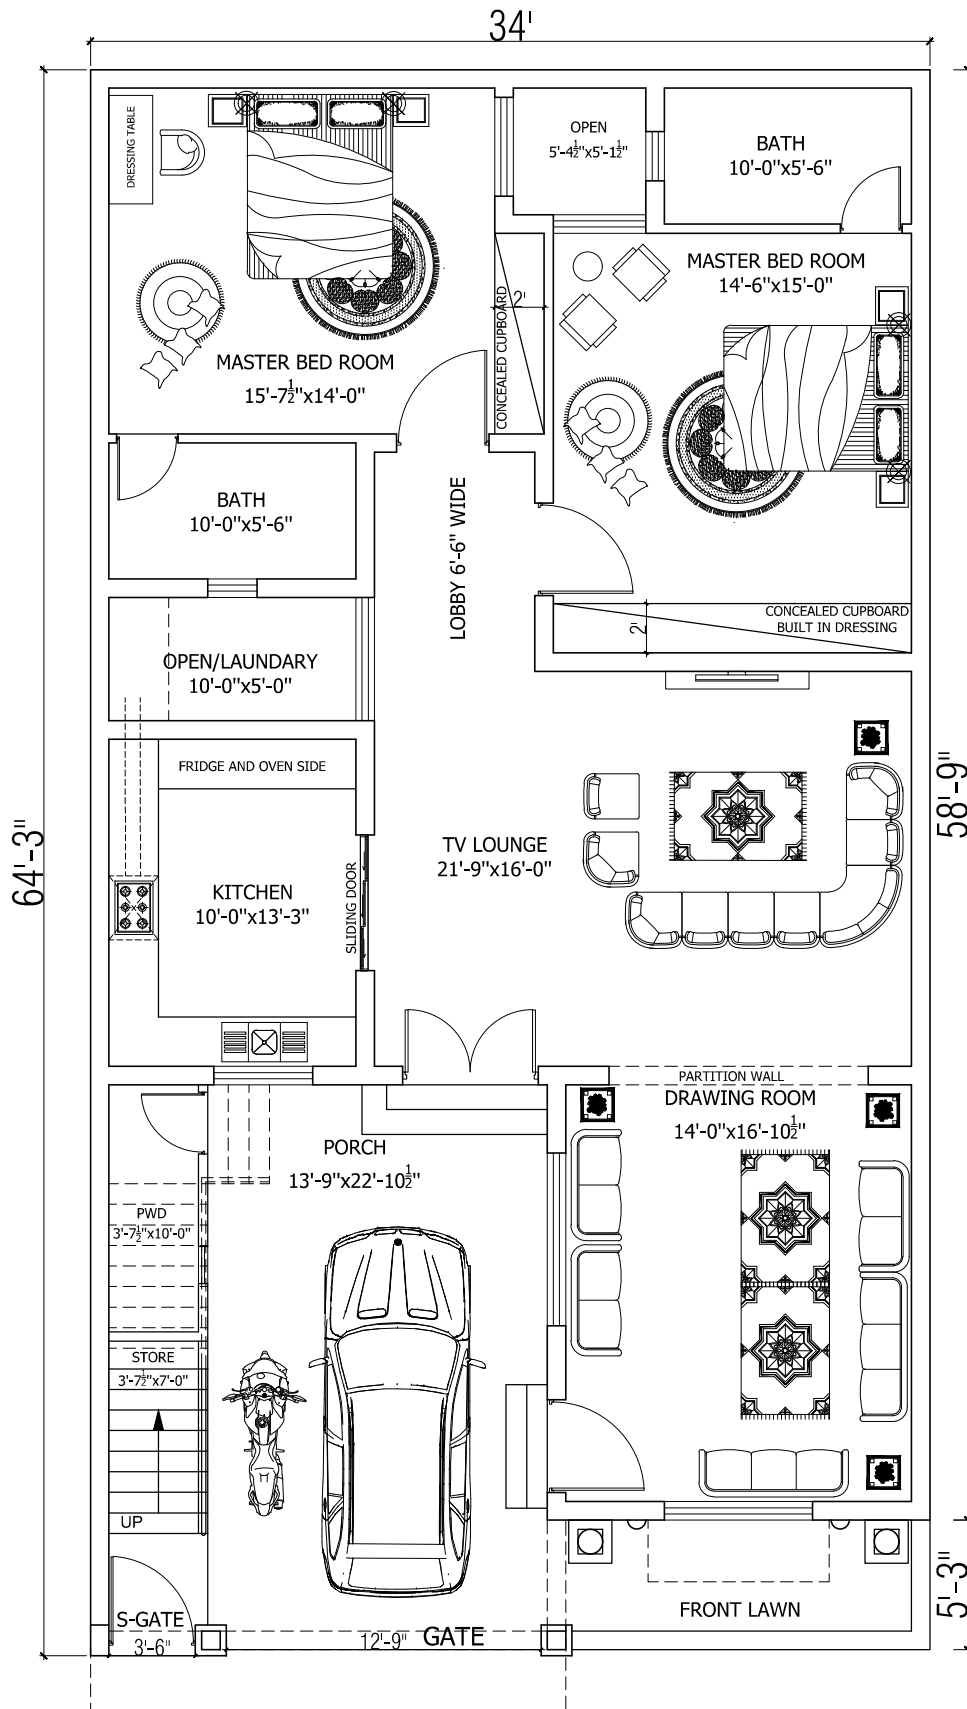

GROUND FLOOR PLAN

FURNITURE LAYOUT




IBN-E-ASGHAR
 & Associates
 Architect, Engineer, Planners,
 Interior designers & Consultants
 Phone: 03087279678

Client: MR. SHOUKAT HUSSAIN
 Project: BUR-E-WALA

Title: FURNITURE LAYOUT
 Sub-title: GROUND FLOOR PLAN

Date: 05-09-2025
 Scale: N.T.S

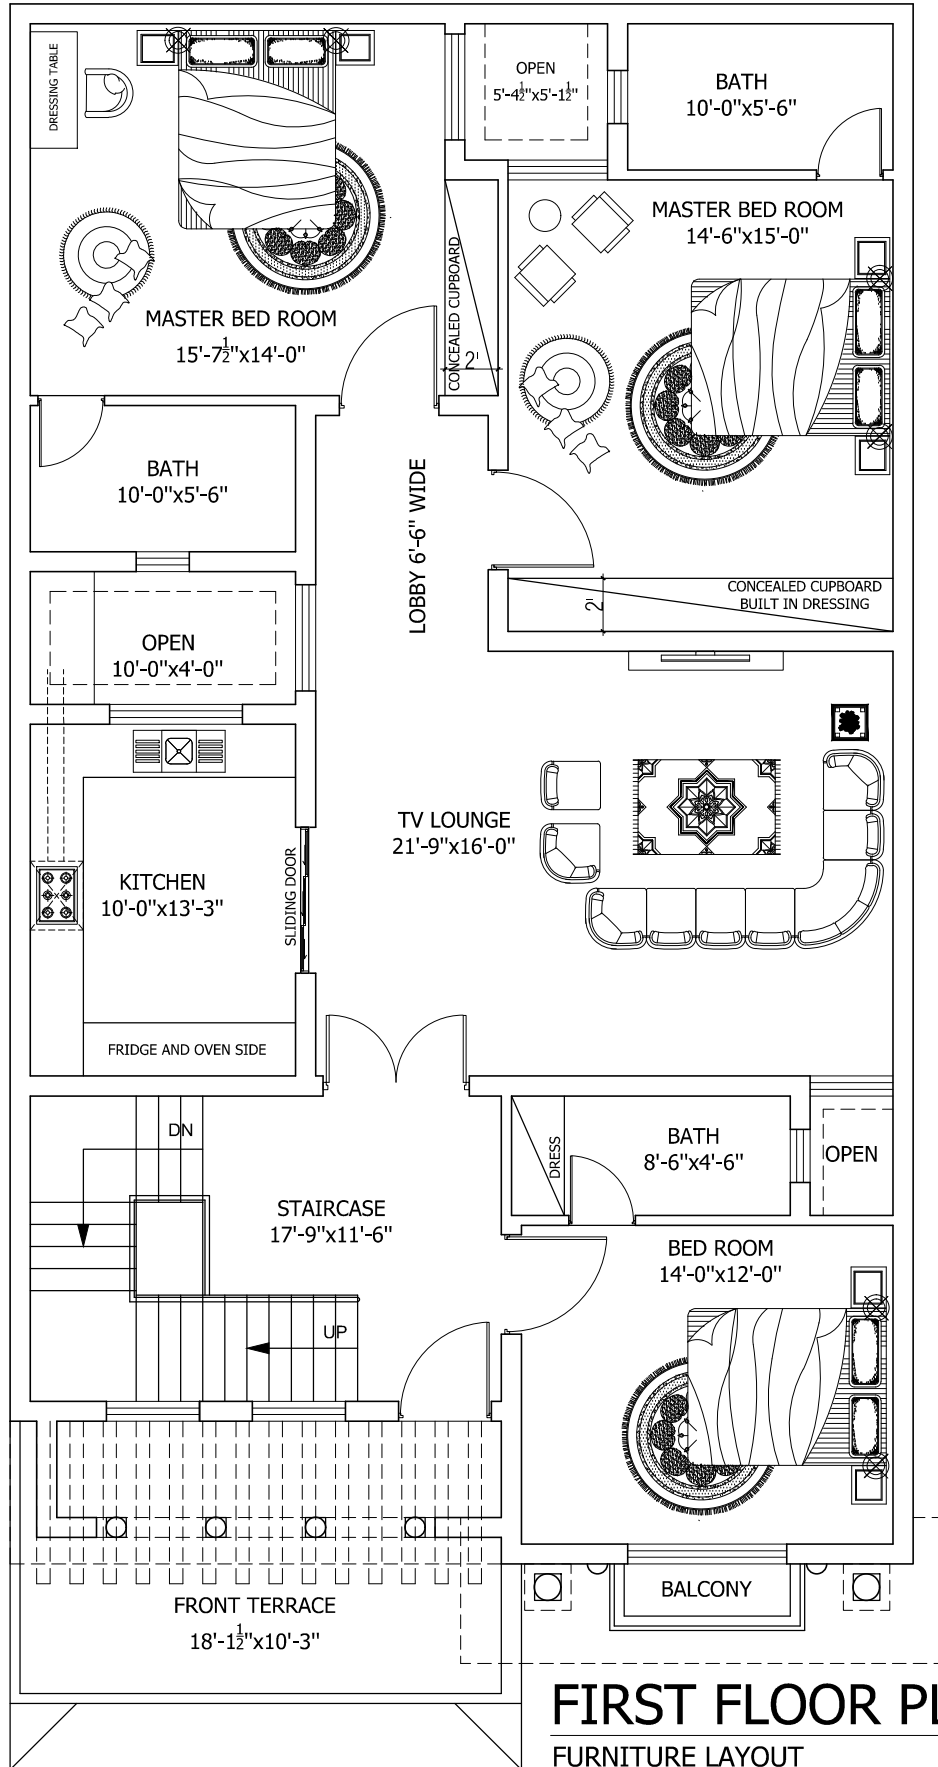

FIRST FLOOR PLAN **FURNITURE LAYOUT**



IBN-E-ASGHAR
& Associates
 Architect, Engineer, Planners,
 Interior designers & Consultants
 Phone: 03087279678

Client:
 MR. SHOUKAT HUSSAIN


Project:
 BUR-E-WALA

Title:
 FURNITURE LAYOUT

Sub-title:
 FIRST FLOOR PLAN

Date:
 05-09-2025

Scale:
 N.T.S

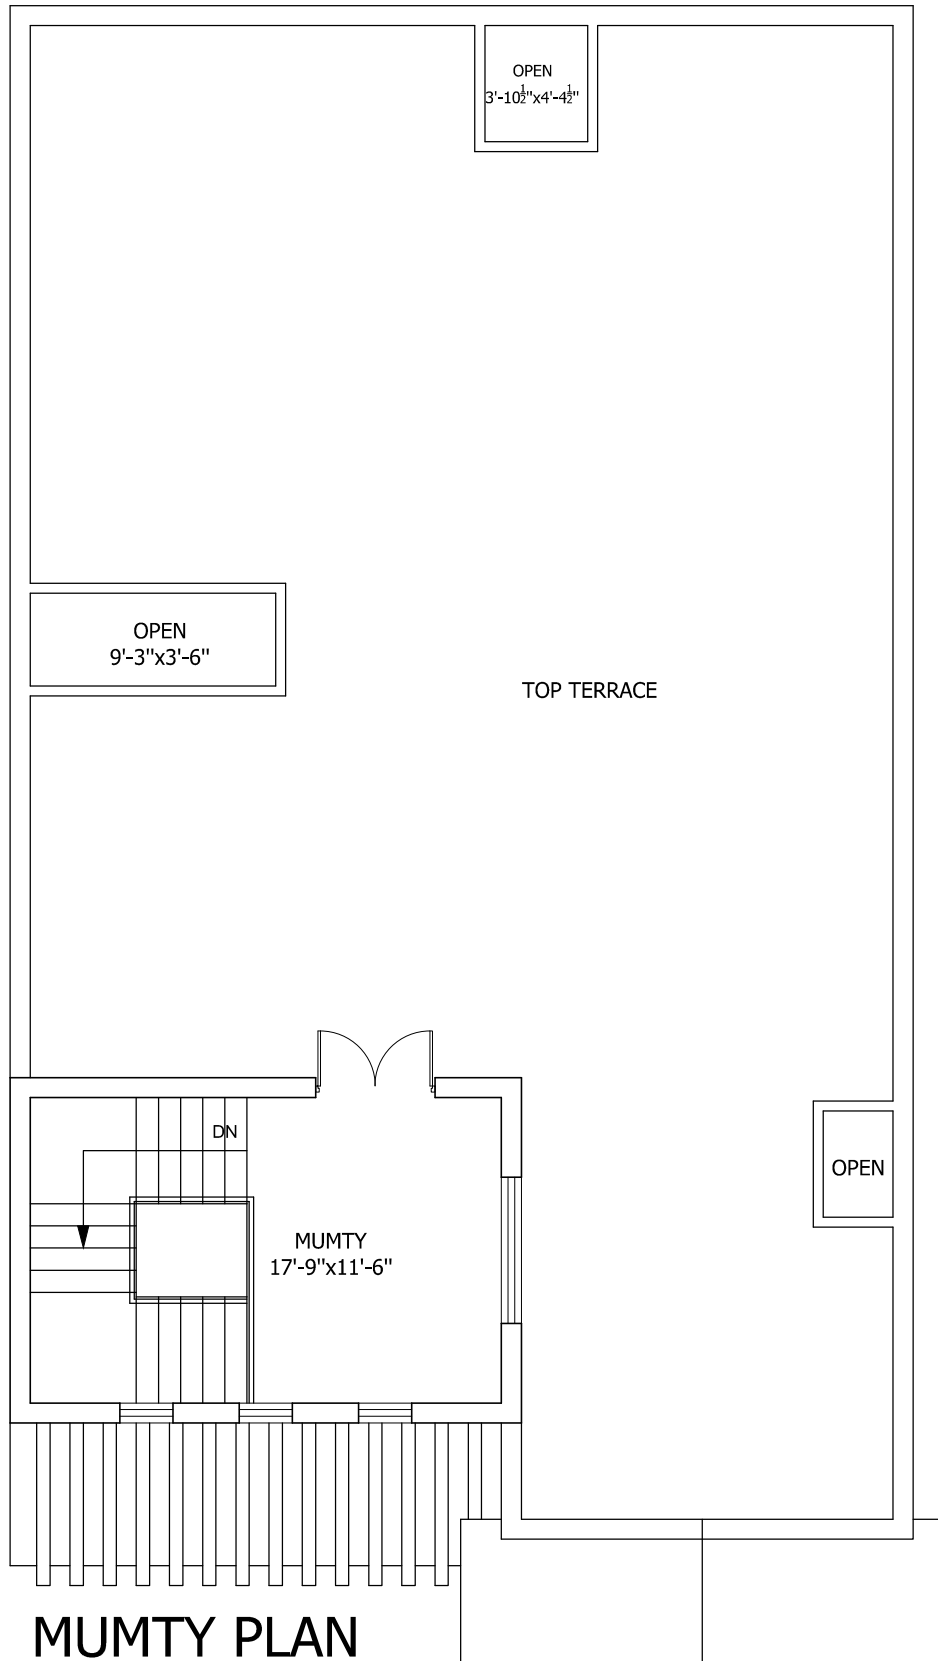

MUMTY PLAN

WORKING DETAILS



**IBN-E-ASGHAR
& Associates**
Architect, Engineer, Planners,
Interior designers & Consultants
Phone: 03087279678

Client: MR. SHOUKAT HUSSAIN
Project: BUR-E-WALA

Title: FURNITURE LAYOUT
Sub-title: MUMTY FLOOR PLAN

Date: 05-09-2025
Scale: N.T.S




IBN-E-ASGHAR
& Associates
Architect, Engineer, Planners,
Interior designers &
Consultants

Client: MR. SHOUKAT HUSSAIN
Project: BUREWALA

Title: FINAL ELEVATION
Sub-title: FRONT ELEVATION

Date: 05-09-2025
Scale: N.T.S

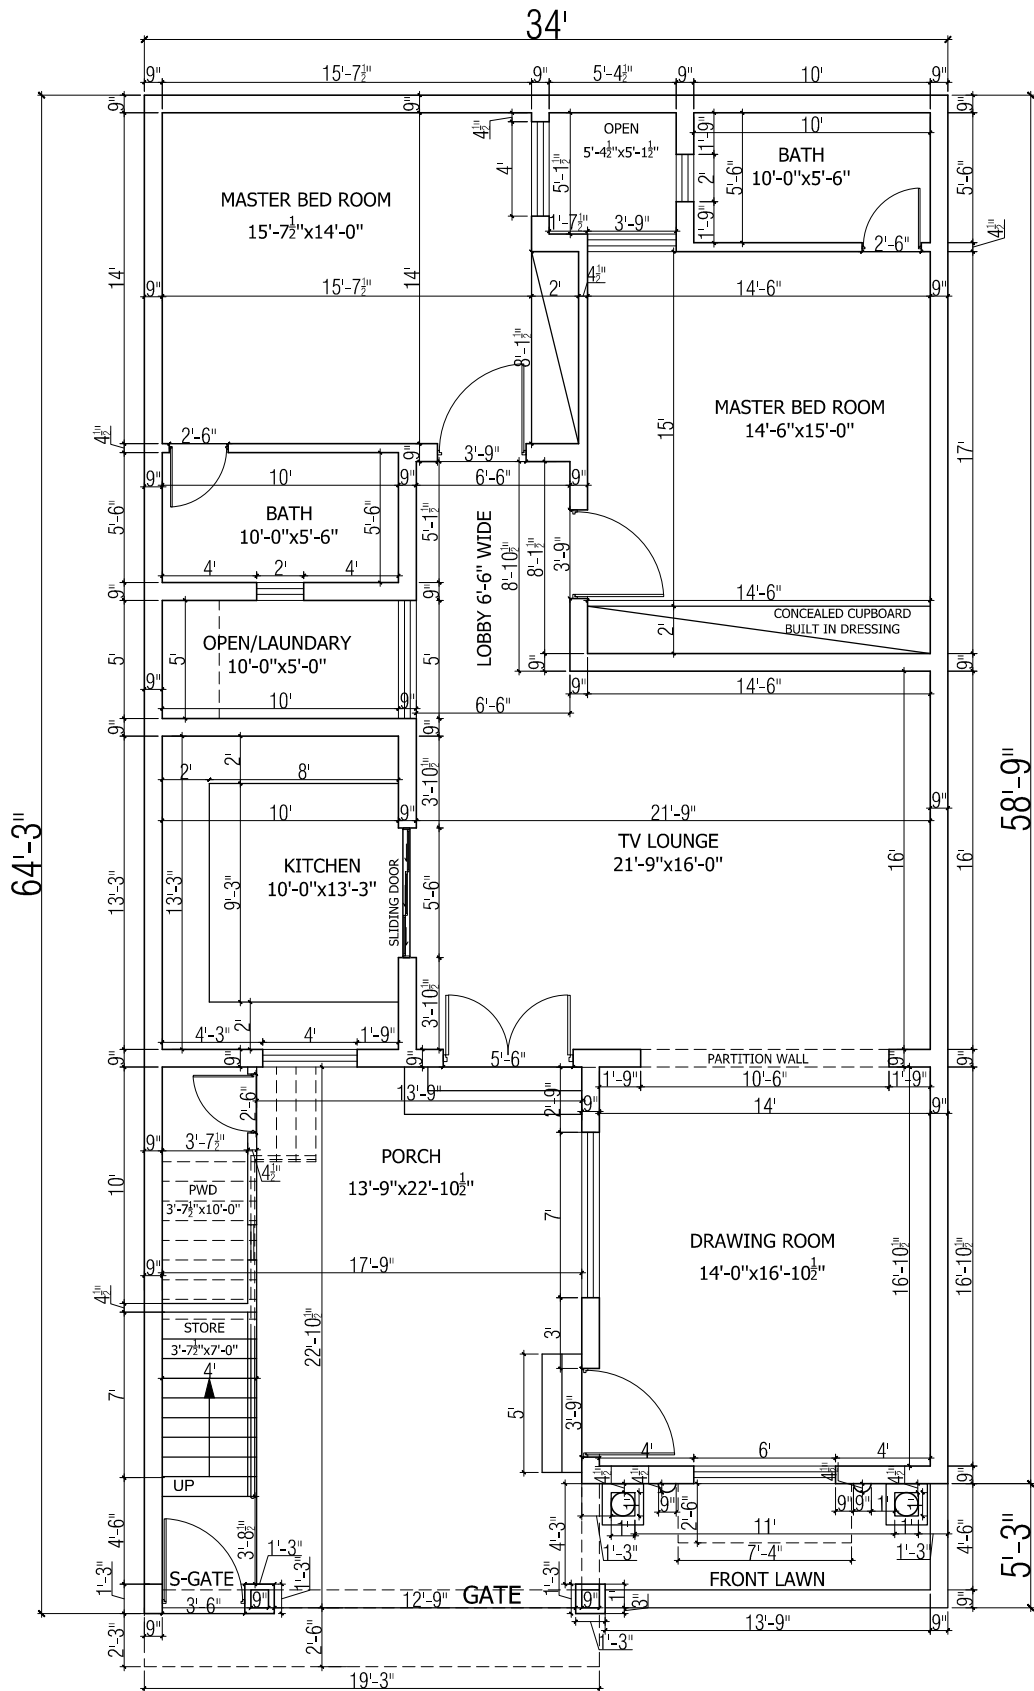

GROUND FLOOR PLAN

WORKING DETAILS




IBN-E-ASGHAR
& Associates
Architect, Engineer, Planners,
Interior designers & Consultants
Phone: 03087279678

Client: MR. SHOUKAT HUSSAIN
Project: BUR-E-WALA

Title: WORKING DETAILS
Sub-title: GROUND FLOOR PLAN

Date: 05-09-2025
Scale: N.T.S

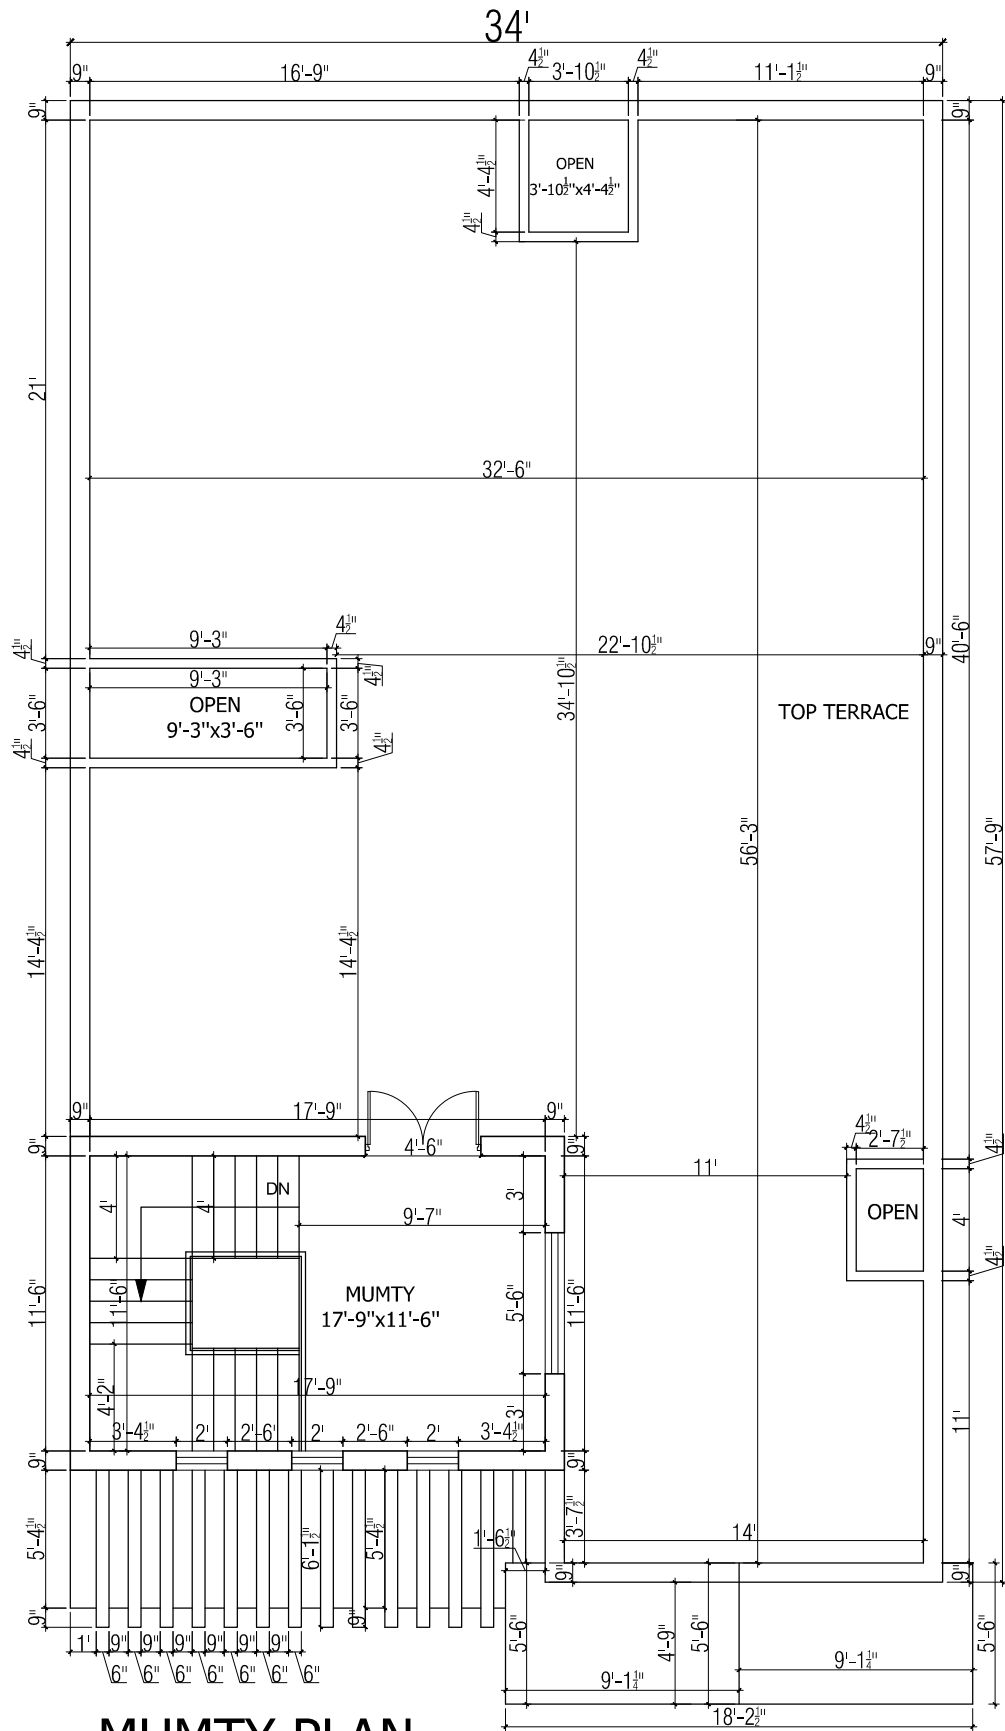

MUMTY PLAN

WORKING DETAILS





IBN-E-ASGHAR
& Associates
Architect, Engineer, Planners,
Interior designers & Consultants
Phone: 03087279678

Client: MR. SHOUKAT HUSSAIN
Project: BUR-E-WALA

Title: WORKING DETAILS
Sub-title: MUMTY FLOOR PLAN

Date: 05-09-2025
Scale: N.T.S

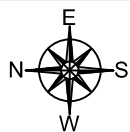
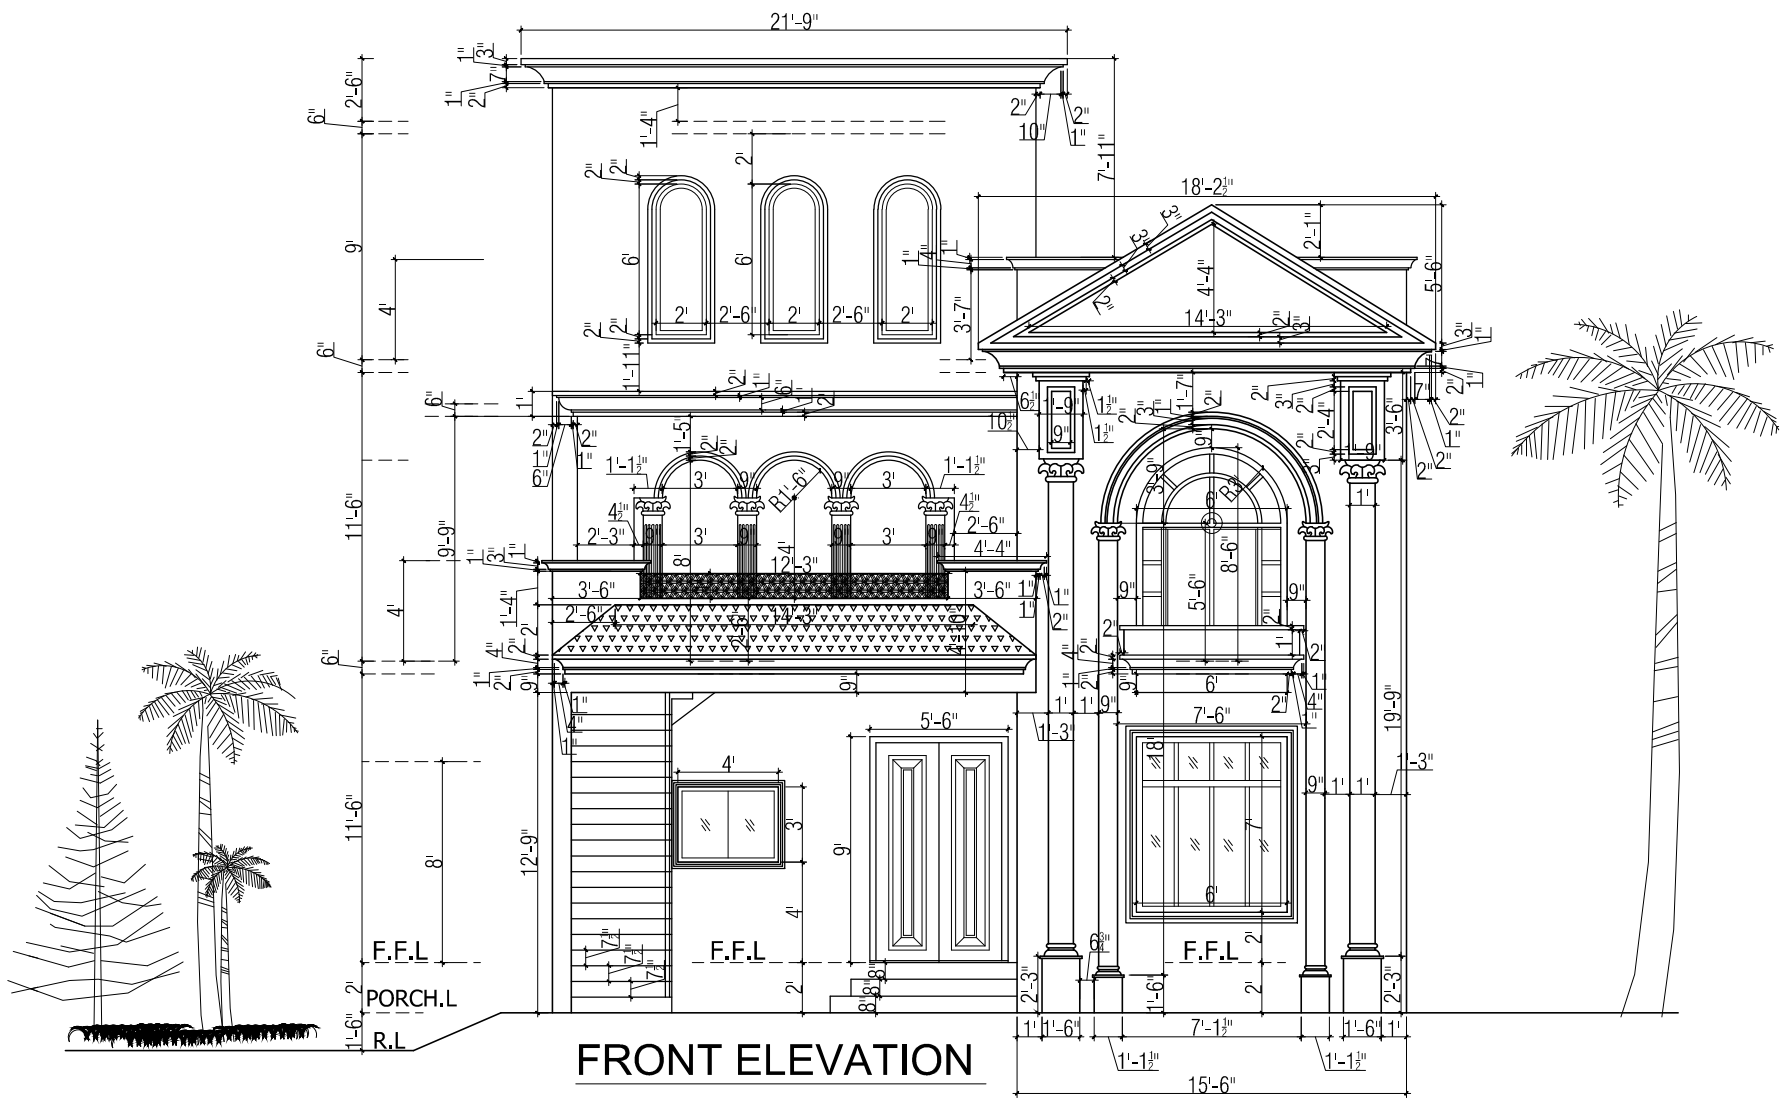


IBN-E-ASGHAR
& Associates
Architect, Engineer, Planners,
Interior designers &
Consultants

Client: MR. SHOUKAT HUSSAIN
Project: BUREWALA

Title: WORKING DETAILS
Sub-title: FRONT ELEVATION

Date: 05-09-2025
Scale: N.T.S

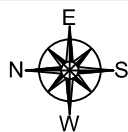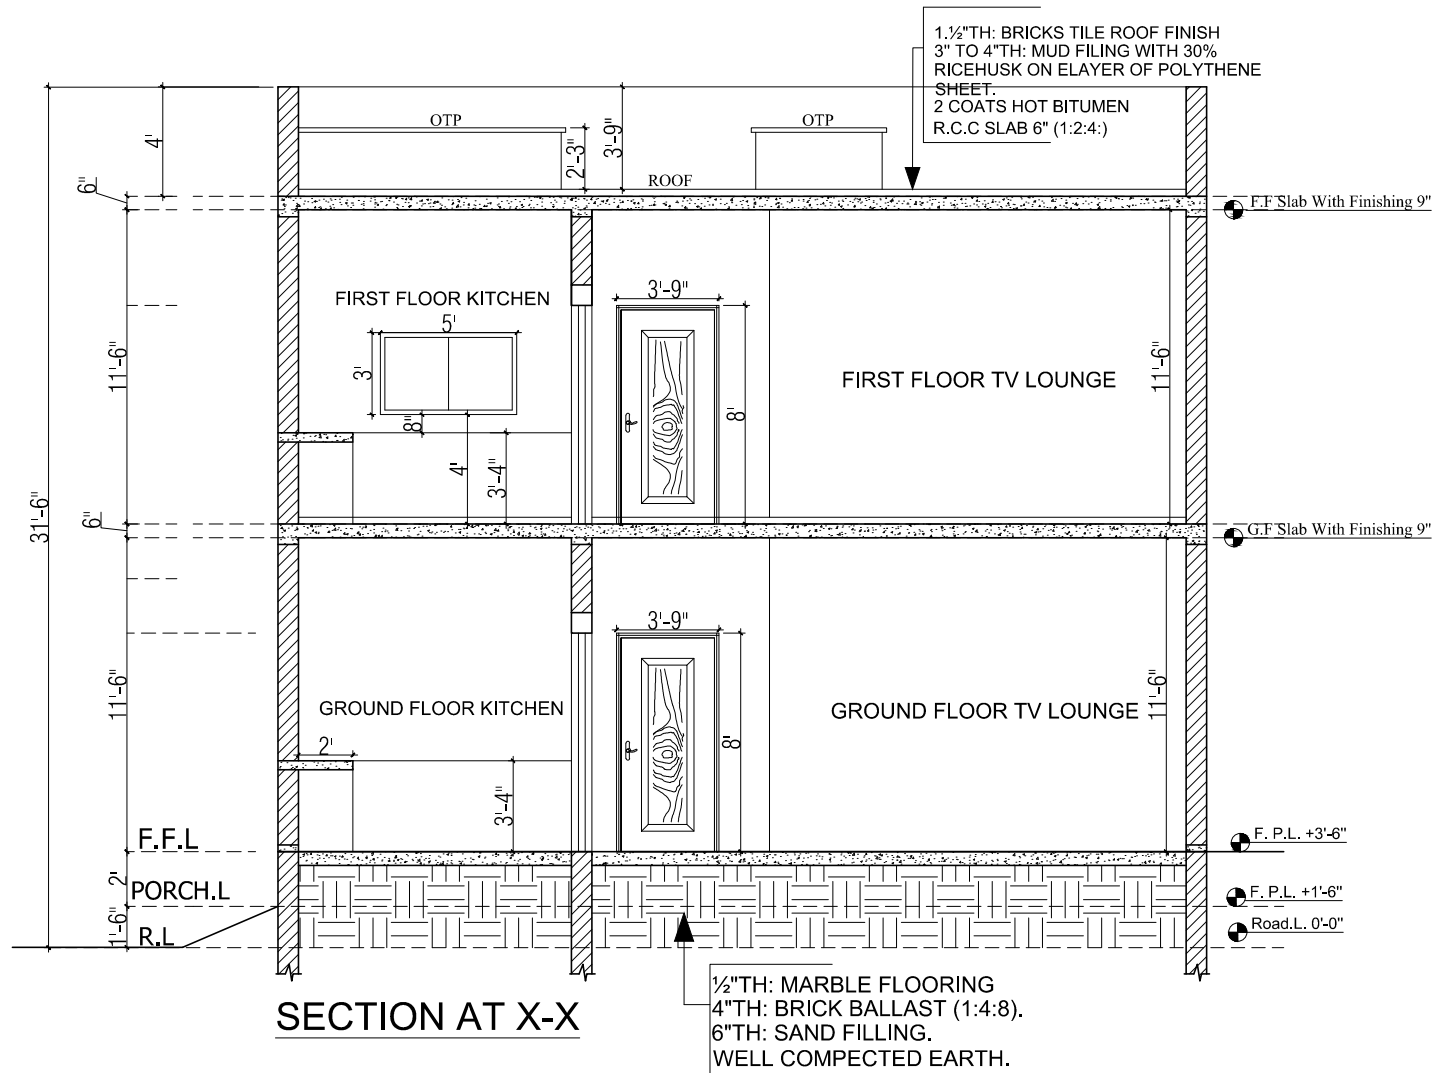


IBN-E-ASGHAR
 & Associates
 Architect, Engineer, Planners,
 Interior designers &
 Consultants

Client: MR. SHOUKAT HUSSAIN
 Project: BUREWALA

Title: X- SECTION DETAILS
 Sub-title: X-X SECTION

Date: 05-09-2025
 Scale: N.T.S

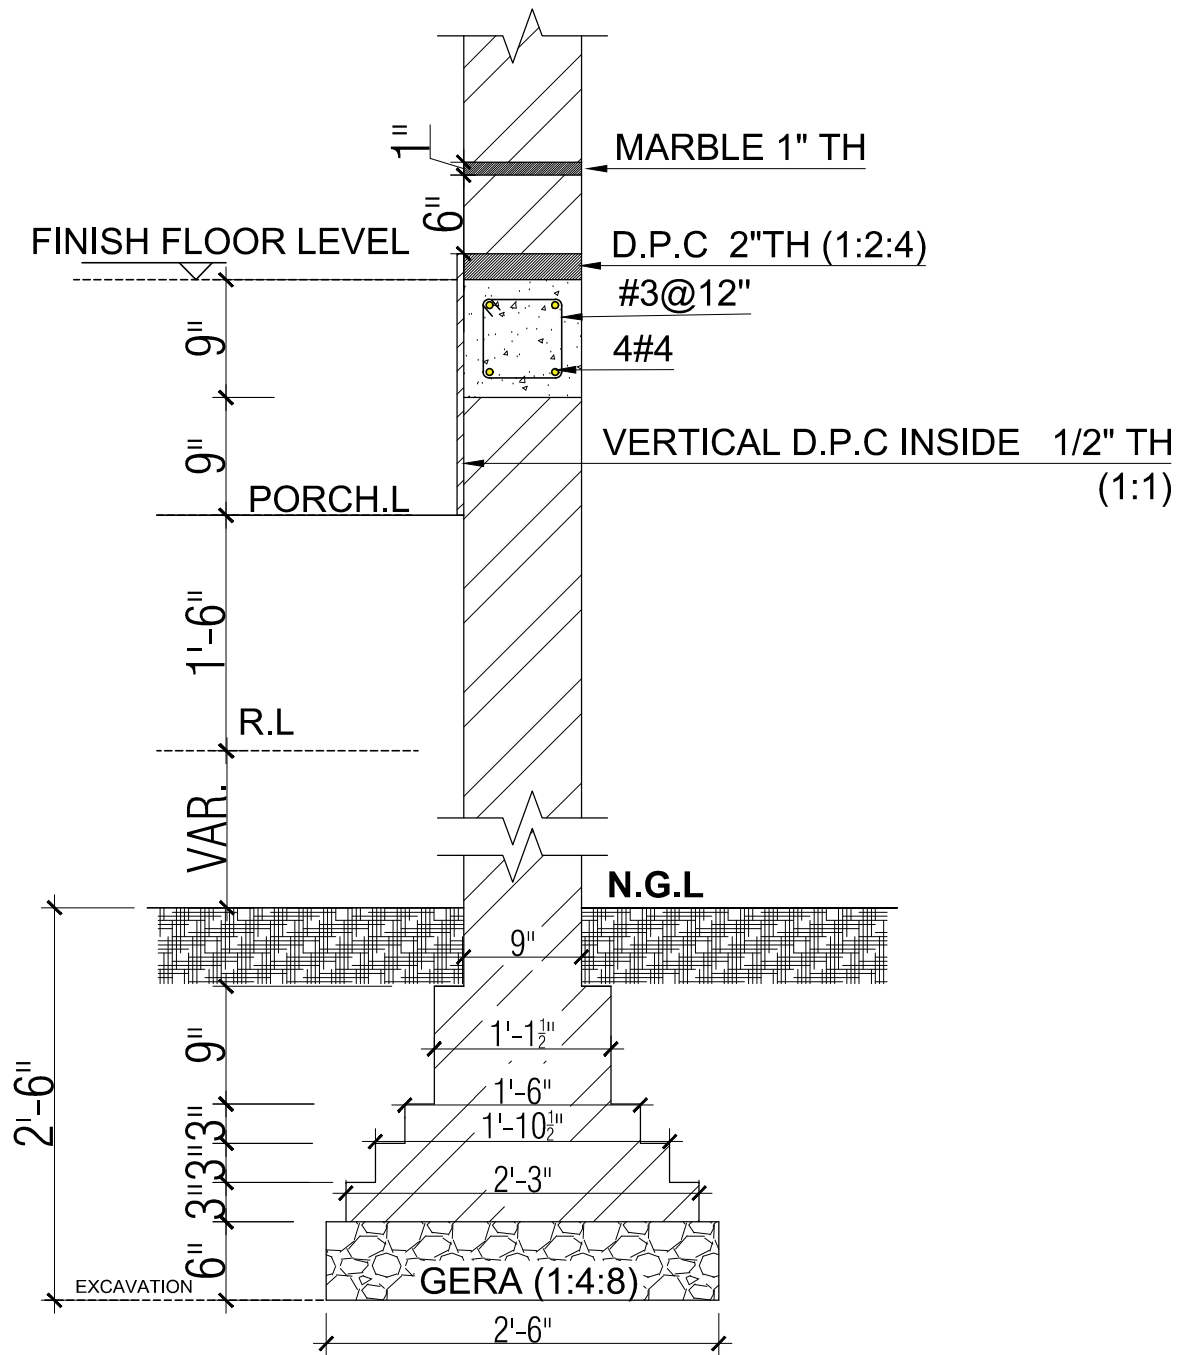

FOUNDATION DETAIL




IBN-E-ASGHAR
& Associates
Architect, Engineer, Planners,
Interior designers &
Consultants

Client: MR SHOUKAT HUSSAIN
Project: BUR-E-WALA

Title: WORK DETAILS
Sub-title: FOUNDATION DETAILS

Date: 05-09-2025
Scale: N.T.S

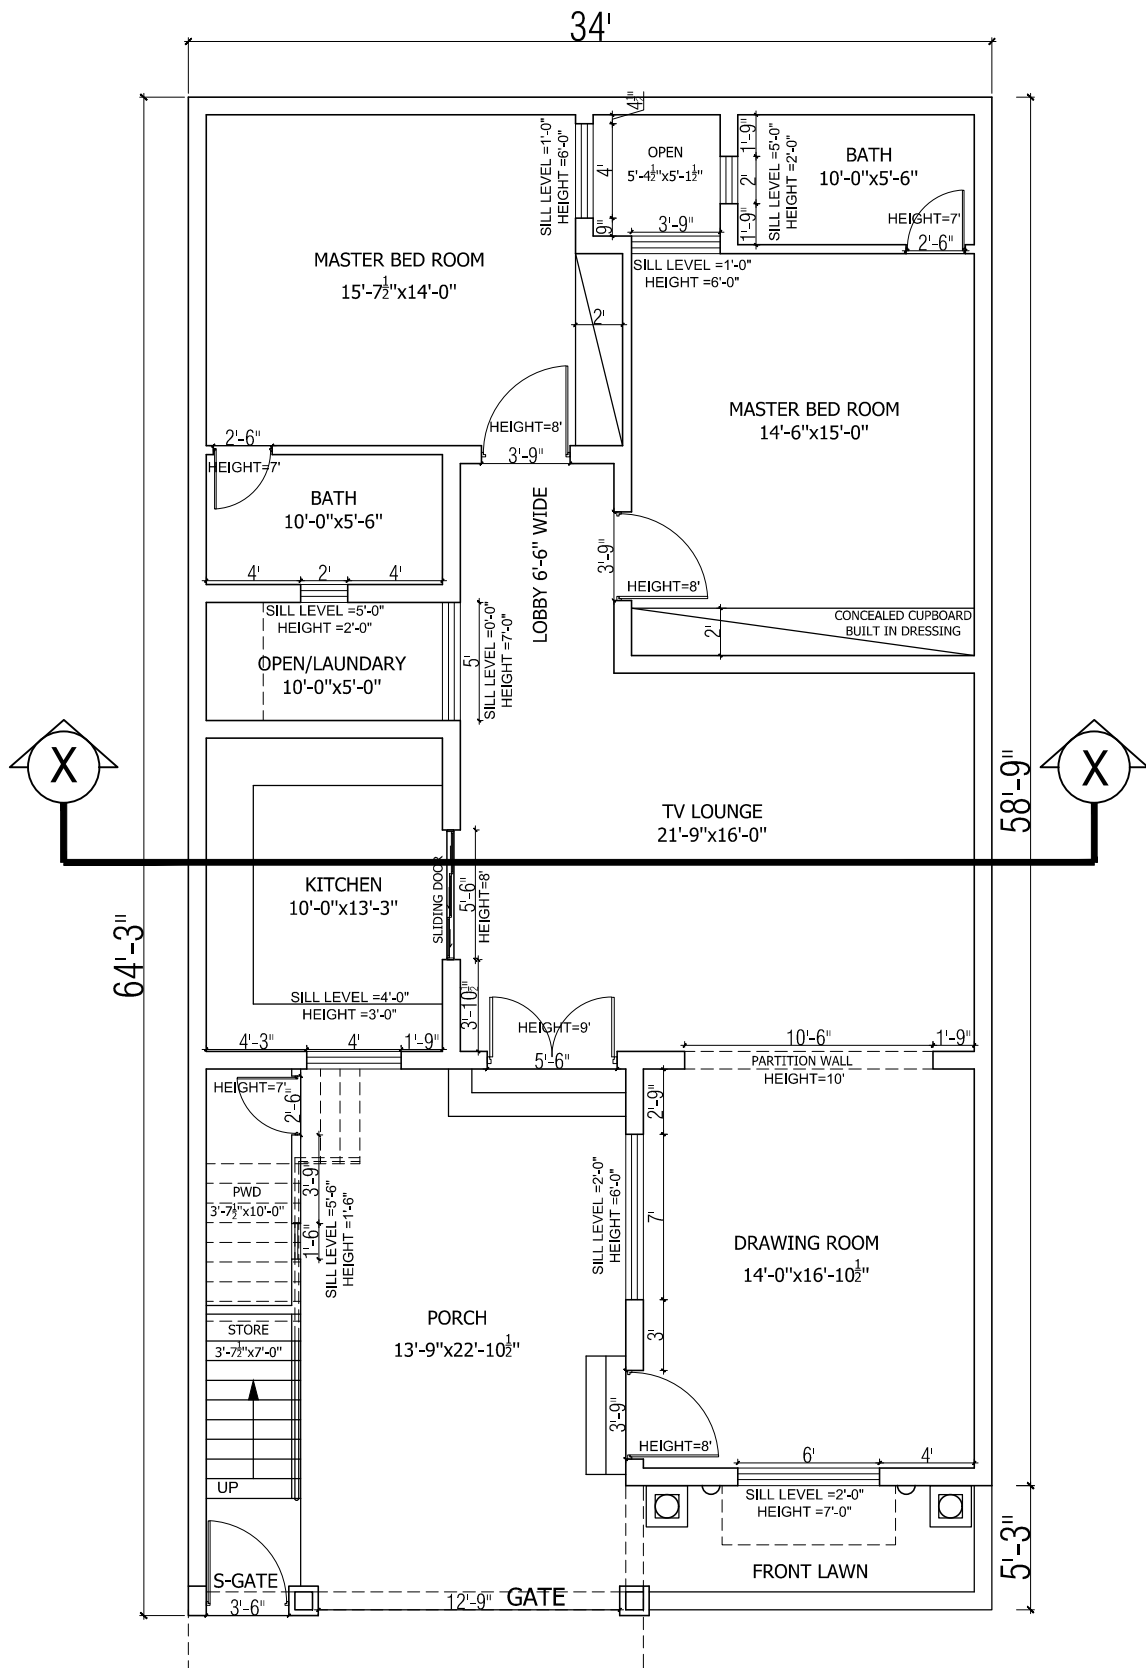

GROUND FLOOR PLAN

DOORS & WINDOWS DETAIL




IBN-E-ASGHAR
& Associates
Architect, Engineer, Planners,
Interior designers & Consultants
Phone: 03087279678

Client: MR. SHOUKAT HUSSAIN
Project: BUR-E-WALA

Title: DOORS & WINDOWS DETAIL
Sub-title: GROUND FLOOR PLAN

Date: 05-09-2025
Scale: N.T.S

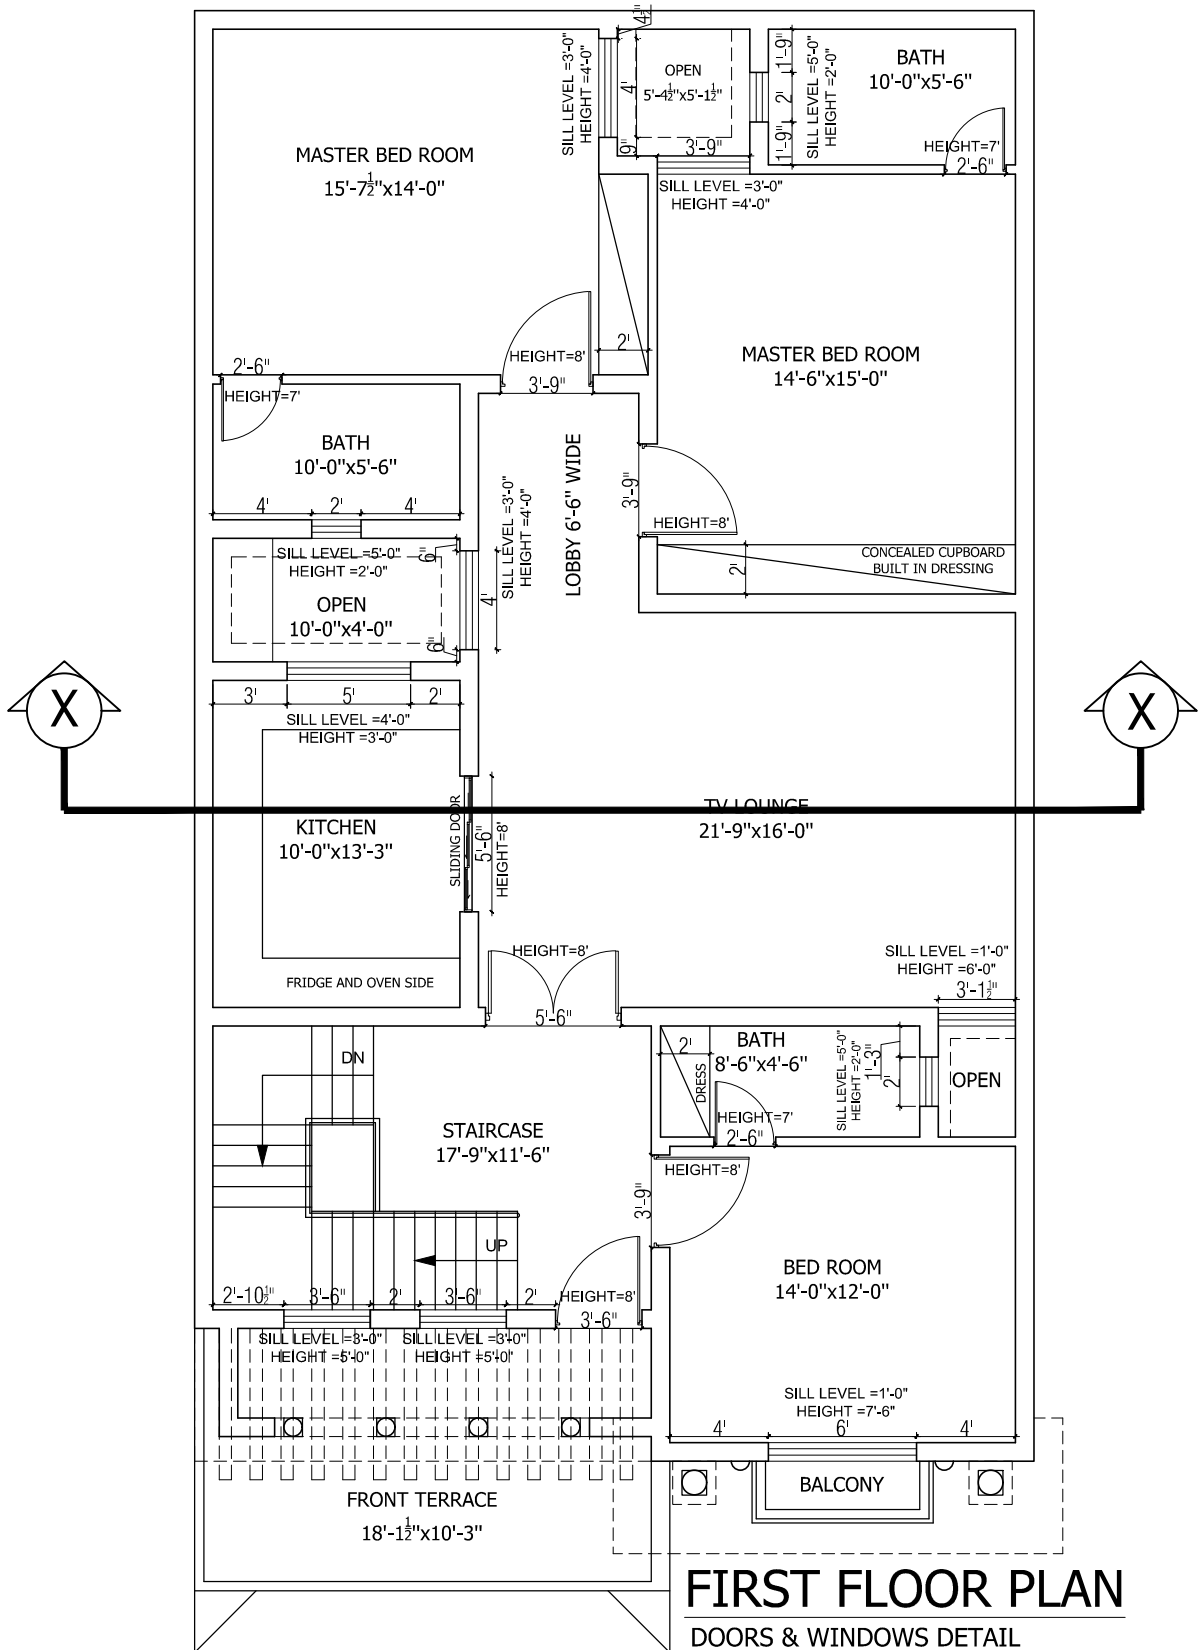

FIRST FLOOR PLAN **DOORS & WINDOWS DETAIL**




IBN-E-ASGHAR
& Associates
Architect, Engineer, Planners,
Interior designers & Consultants
Phone: 03087279678

Client: MR. SHOUKAT HUSSAIN
Project: BUR-E-WALA

Title: DOORS & WINDOWS DETAIL
Sub-title: FIRST FLOOR PLAN

Date: 05-09-2025
Scale: N.T.S

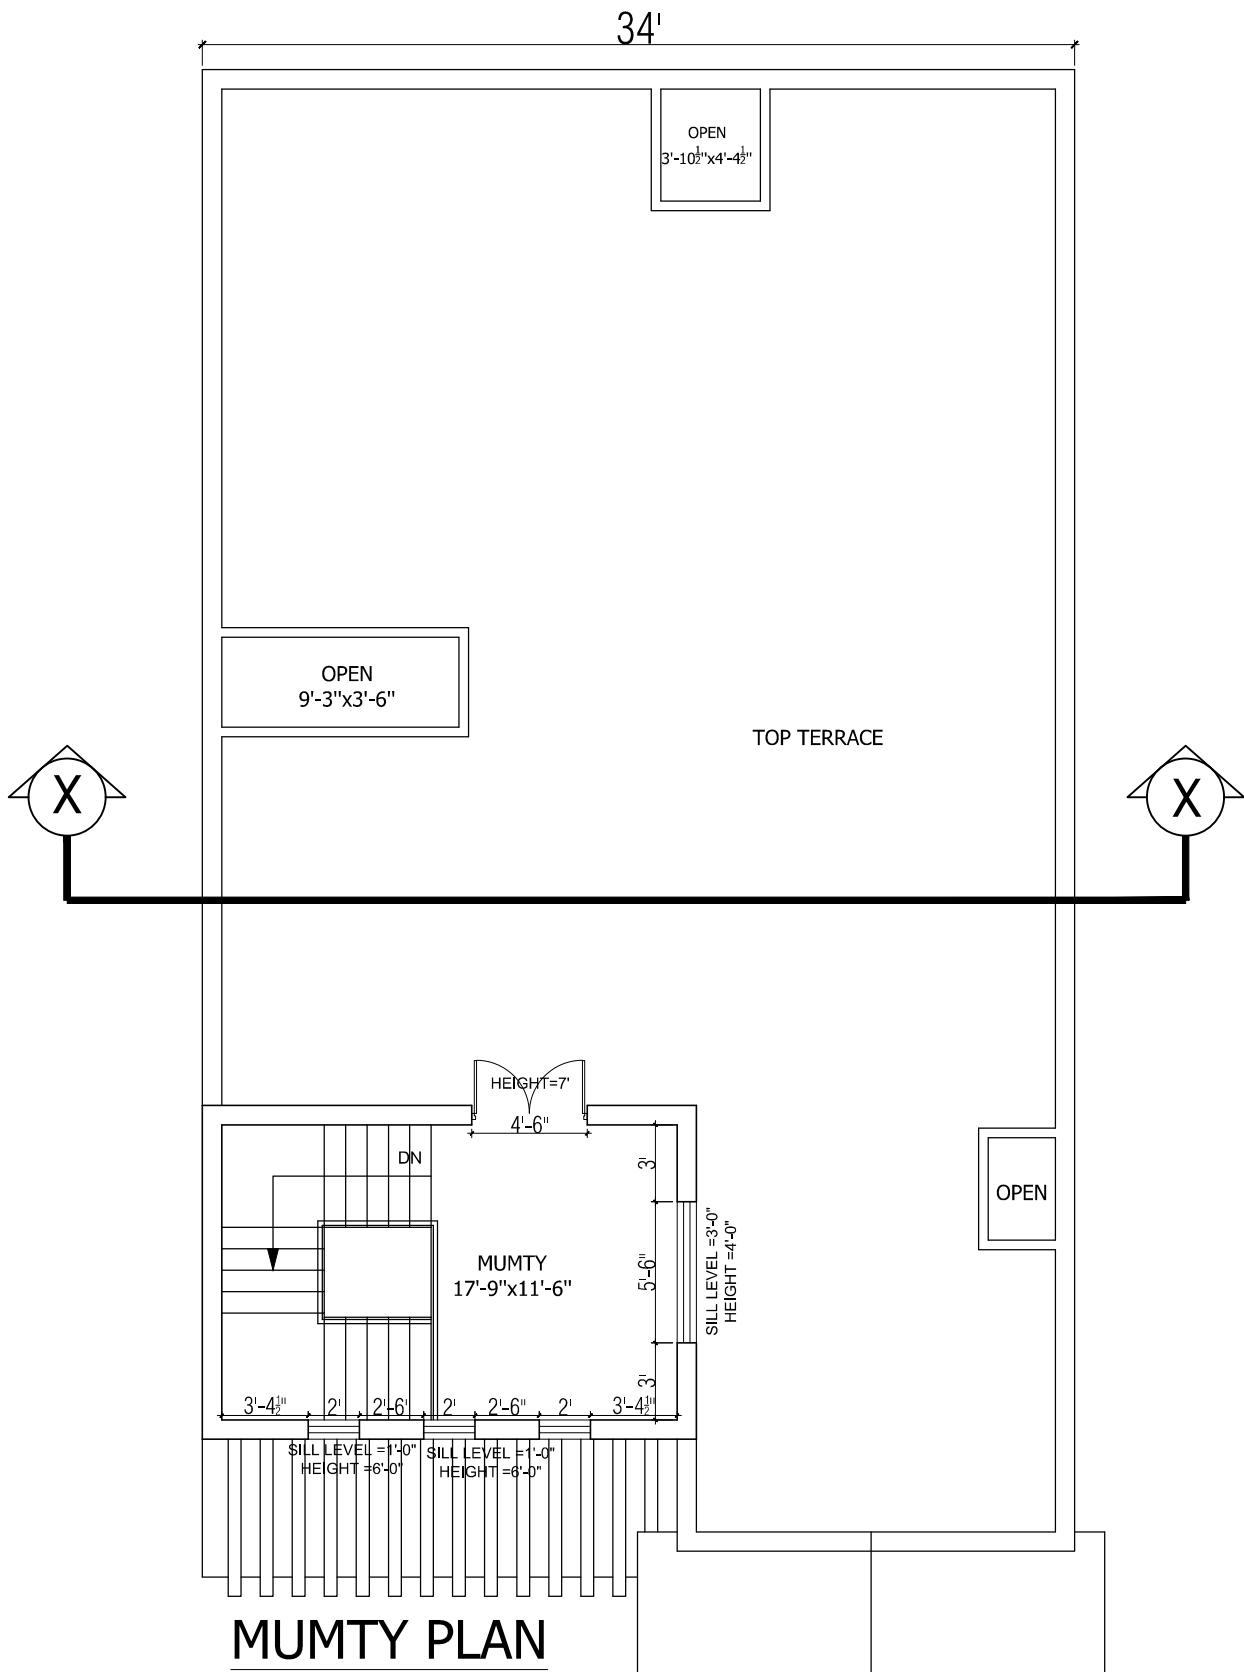

IBN-E-ASGHAR
& Associates
Architect, Engineer, Planners,
Interior designers & Consultants
Phone: 03087279678

Client: MR. SHOUKAT HUSSAIN
Project: BUR-E-WALA

Title: DOORS & WINDOWS DETAIL
Sub-title: MUMTY FLOOR PLAN

Date: 05-09-2025
Scale: N.T.S

FULL HOUSE CHOGATTH

SIZE	WIDTH	PADAAM	QTY	
5'-6" X 9'-0"	10"	DOUBLE	1	G.F MAIN DOOR
5'-6" X 8'-0"	10"	DOUBLE	1	F.F MAIN DOOR
4'-6" X 7'-0"	10"	DOUBLE	1	MUMTY DOOR
3'-9" X 8'-0"	10"	SINGLE	6	DRAWING & BED DOOR
3'-6" X 8'-0"	10"	SINGLE	1	TERRACE DOOR
5'-6" X 8'-0"	10"	SLIDING	2	KITCHEN DOORS
2'-6" X 7'-3"	5"	SINGLE	6	BATH DOORS
		TOTAL = 18		



IBN-E-ASGHAR
& Associates
Architect, Engineer, Planners,
Interior designers &
Consultants

Client: MR SHOUKAT HUSSAIN


Project: BUR-E-WALA

Title: WORK DETAILS

Sub-title: CHOGATH DETAILS

Date: 05-09-2025

Scale: N.T.S

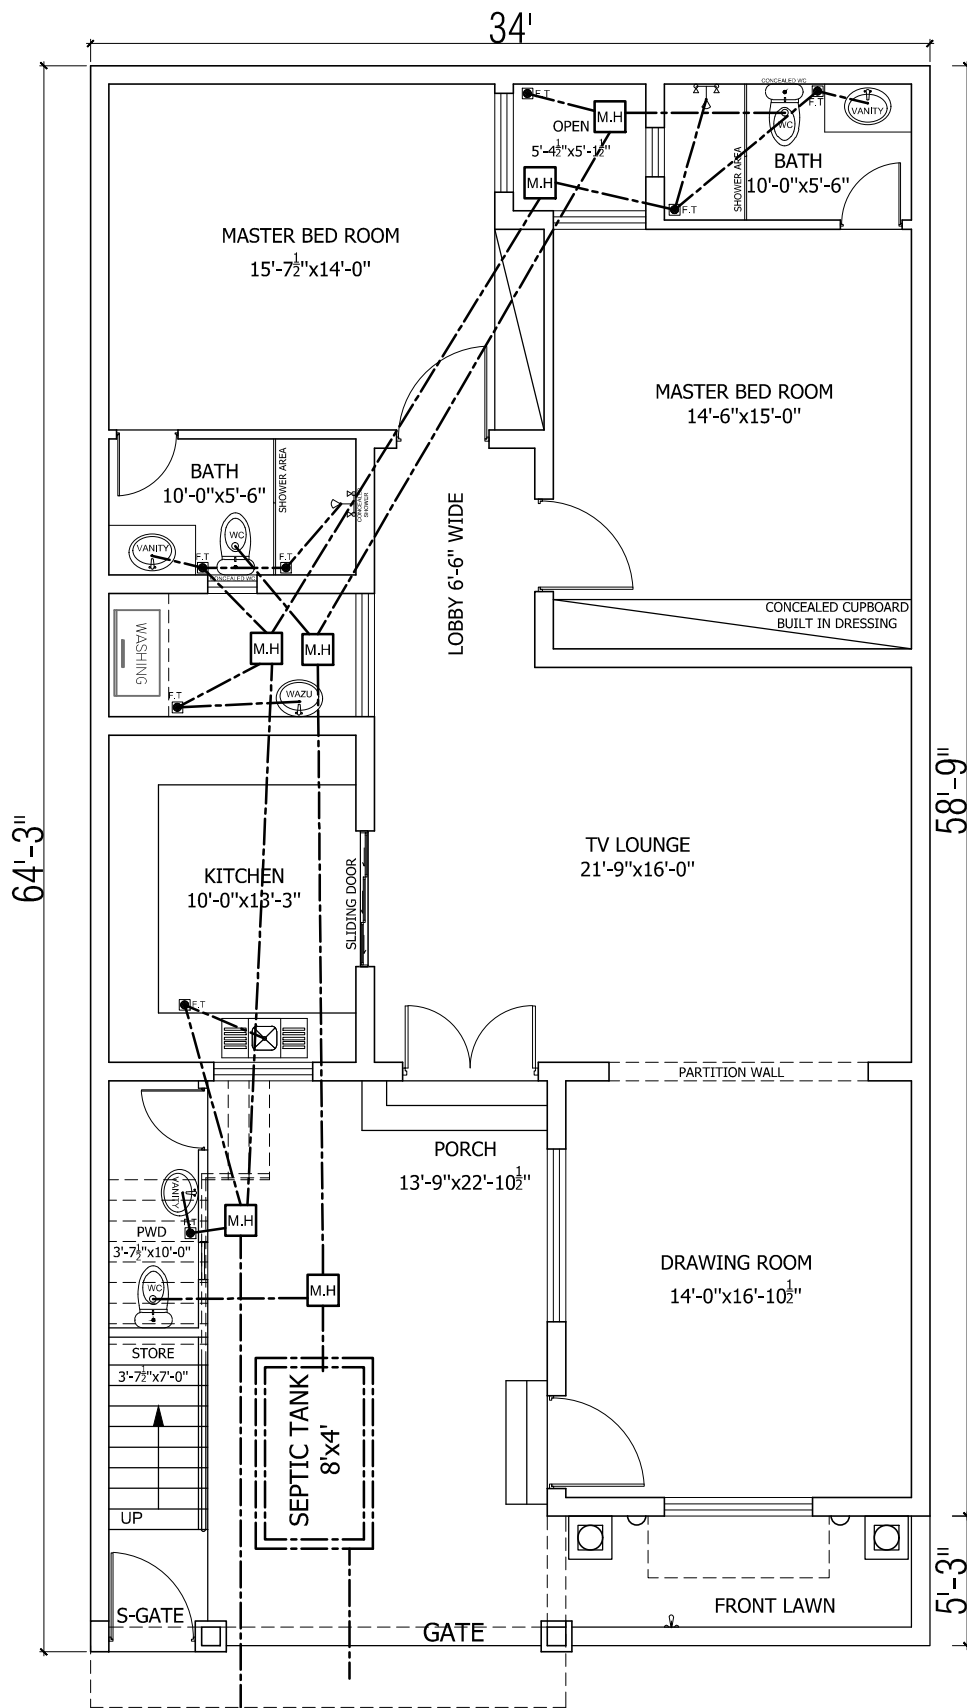

GROUND FLOOR PLAN

PLUMBING WORK DETAILS




**IBN-E-ASGHAR
& Associates**
Architect, Engineer, Planners,
Interior designers & Consultants
Phone: 03087279678

Client: MR. SHOUKAT HUSSAIN
Project: BUR-E-WALA

Title: PLUMBING WORK DETAILS
Sub-title: GROUND FLOOR PLAN

Date: 05-09-2025
Scale: N.T.S

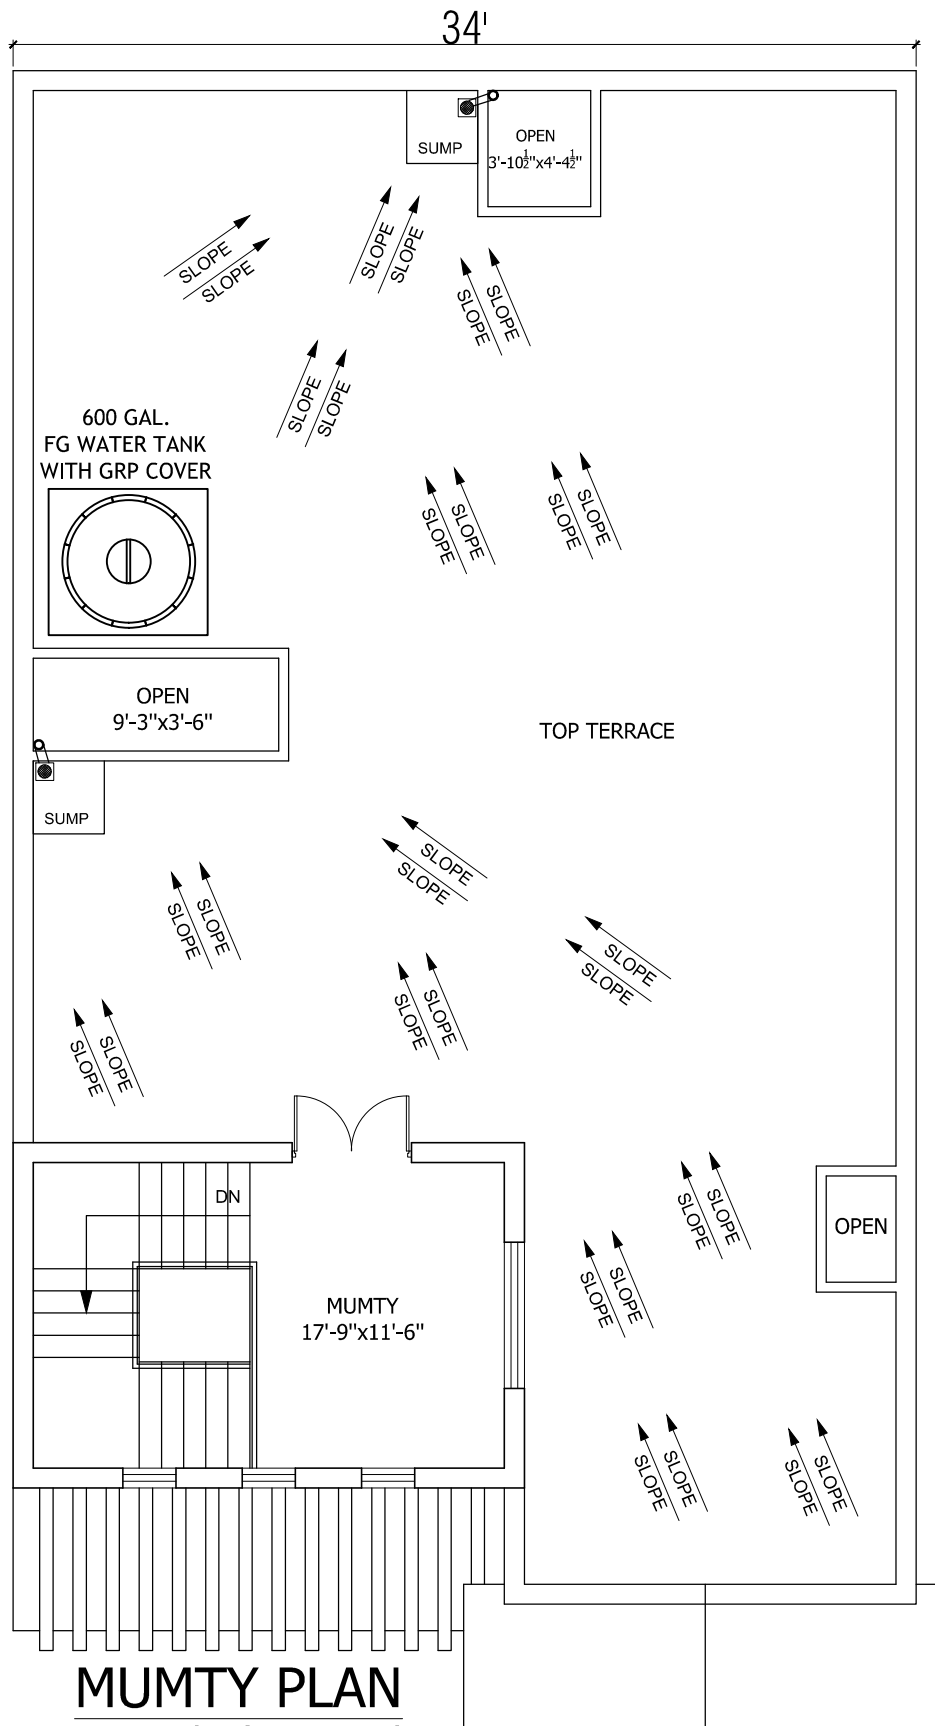

MUMTY PLAN
PLUMBING WORK DETAILS




IBN-E-ASGHAR
& Associates
Architect, Engineer, Planners,
Interior designers & Consultants
Phone: 03087279678

Client: MR. SHOUKAT HUSSAIN
Project: BUR-E-WALA

Title: PLUMBING WORK DETAILS
Sub-title: MUMTY FLOOR PLAN

Date: 05-09-2025
Scale: N.T.S

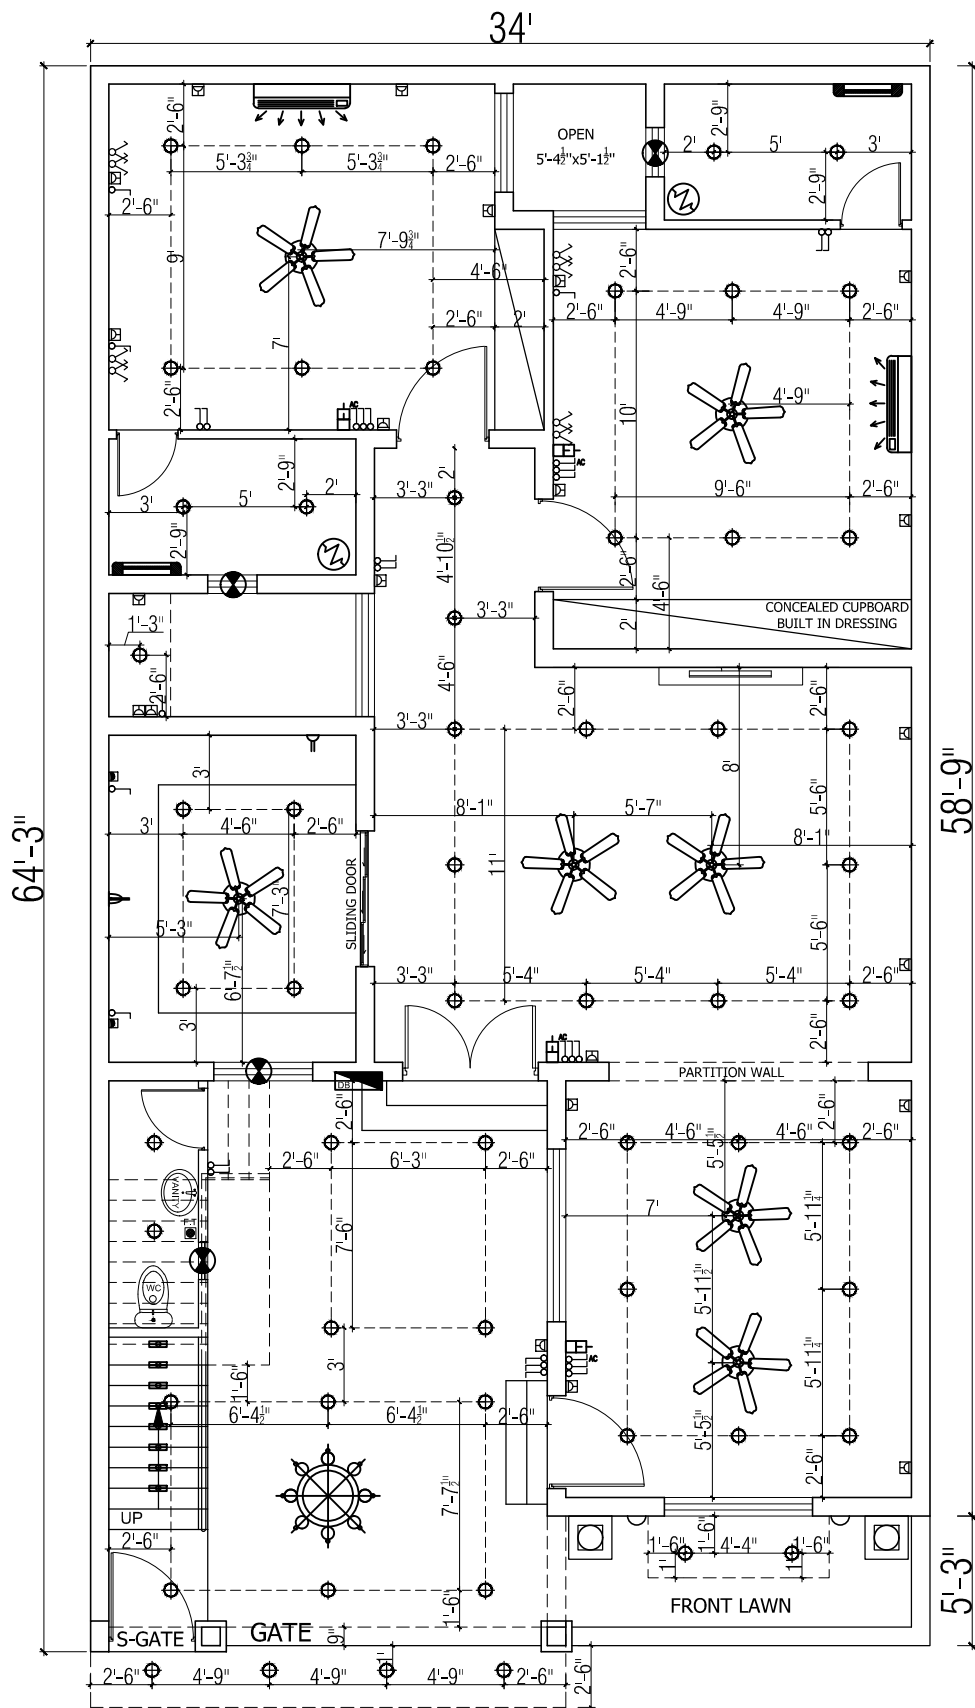


IBN-E-ASGHAR
& Associates
Architect, Engineer, Planners,
Interior designers & Consultants
Phone: 03087279678

Client: MR. SHOUKAT HUSSAIN
Project: BUR-E-WALA

Title: ELECTRIC WORK DETAILS
Sub-title: GROUND FLOOR PLAN

Date: 05-09-2025
Scale: N.T.S


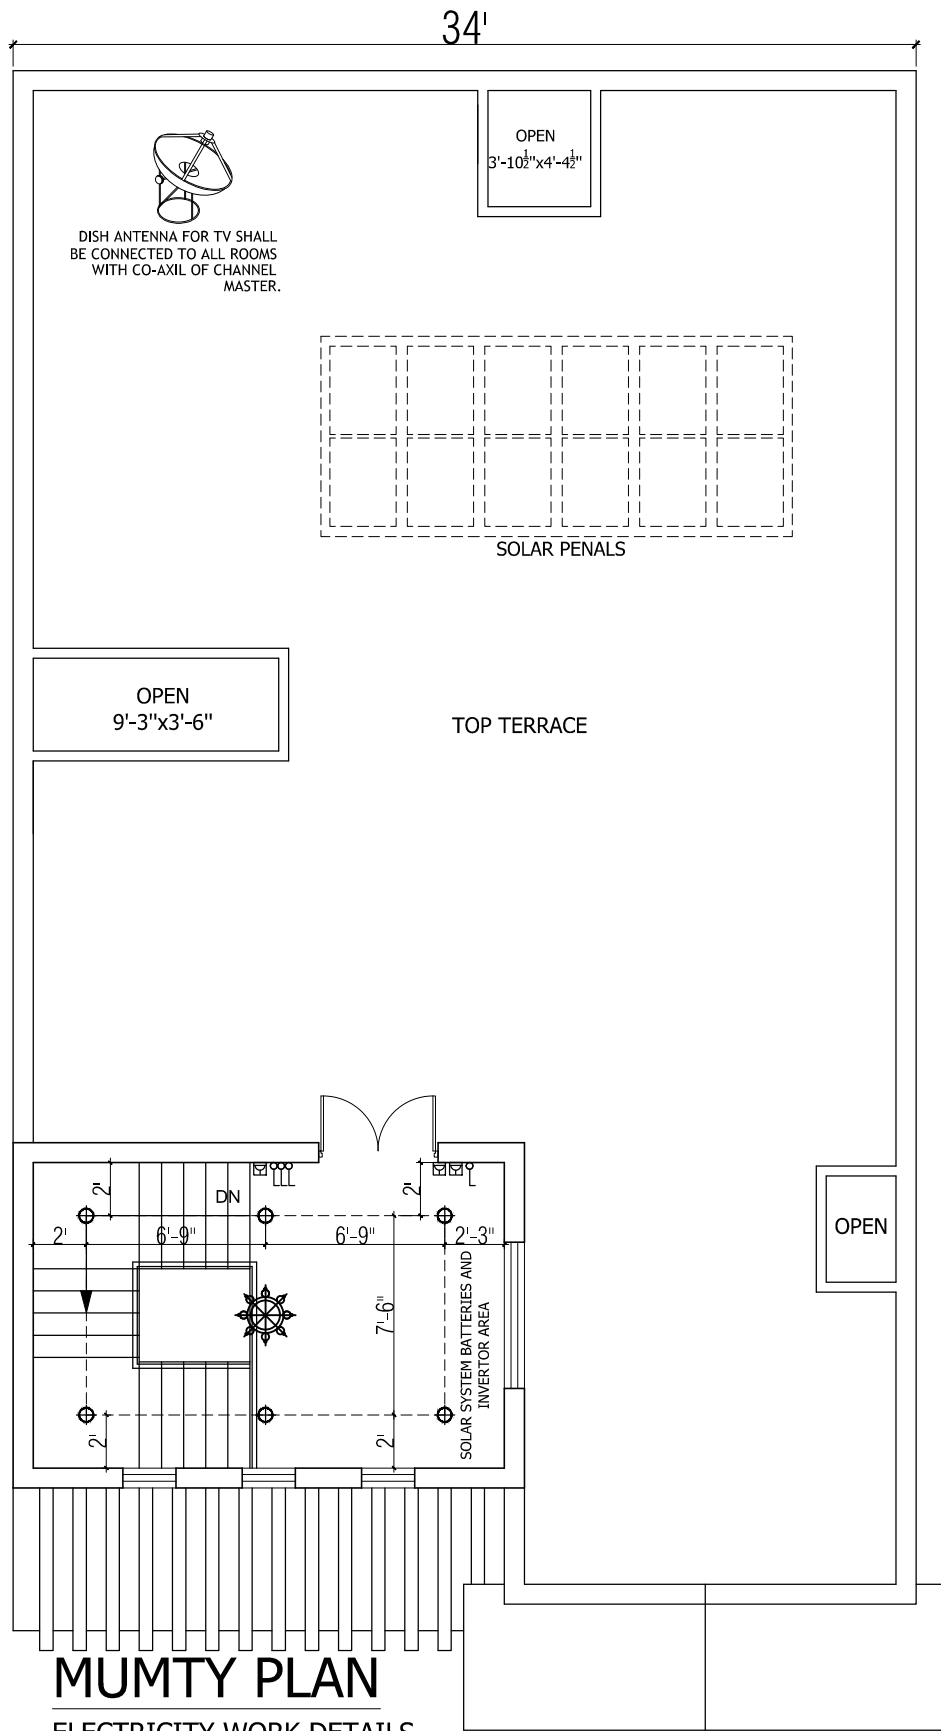


IBN-E-ASGHAR
& Associates
Architect, Engineer, Planners,
Interior designers & Consultants
Phone: 03087279678

Client: MR. SHOUKAT HUSSAIN
Project: BUR-E-WALA

Title: ELECTRIC WORK DETAILS
Sub-title: MUMTY FLOOR PLAN

  Date: 05-09-2025
Scale: N.T.S

ELECTRICAL LEGEND			
SYMBOL	DESCRIPTION	SYMBOL	DESCRIPTION
	ONE WAY SWITCH		LED DOWN LIGHT
	SWITCH FOR AC		WP WALL LIGHT
	TWO WAY SWITCH		MIRROR LIGHT FIXTURE
	WATER HEATER SWITCH		FLUORESCENT DOUBLE TUBE LIGHT
	2X13 A SWITCHED SOCKET OUTLET		CHANDLIER LIGHT
	VOICE & DATA OUTLET POINT		15 A SWITCHED SOCKET
	INTERCOM POINT	WP	WEATHER PROOF
	TV OUTLET POINT		DISTRIBUTION BOARD
	COOKER SOCKET AND SWITCH		WATER HEATER
	DECORATIVE WALL LIGHT		FRIDGE SOCKET AND SWITCH
	CEILING FAN		EXHAUST FAN
	FAN REGULATOR		SIDE THROW GRILL A/C
	SPLIT UNIT		BOTTOM THROW GRILL A/C
	STEP LIGHT		CIRCULAR LIGHT



IBN-E-ASGHAR
& Associates
Architect, Engineer, Planners,
Interior designers &
Consultants

Client: MR. SHOUKAT HUSSAIN
Project: BUR-E-WALA

Title: ELECTRICITY WORK DETAILS
Sub-title: SYMBOLS DETAIL

Date: 05-09-2025
Scale: N.T.S